




GOVERNMENT OF BERMUDA

MINISTRY OF PUBLIC WORKS  
DEPARTMENT OF WORKS AND ENGINEERING

ELECTRICAL AND MECHANICAL ENGINEERING SECTION  
P.O. Box HM 1365 Hamilton HMF Bermuda  
Tel: (441) 295-5151  
Fax: (441) 295-4675

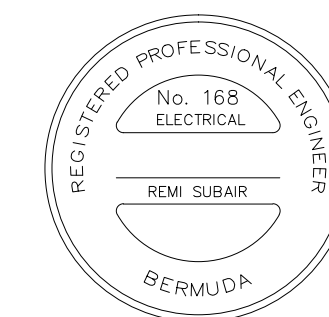

ISSUE / REVISION

No.	Revision	Date
4	REVIEW	MAR. 19, 2013
3	BUILDING PERMIT	DEC. 19, 2012
2	REVIEW	NOV. 23, 2012
1	REVIEW	JULY 3, 2012

SCALE: AS NOTED

**SURVEY**  
Prepared By: - Date: -

**DESIGN**  
Prepared By: RS Date: NOV. 2012  
Checked By: - Date: -

**DRAWING**  
Prepared By: RS Date: NOV. 2012  
Checked By: - Date: -

Approved By: RS Date: NOV. 2012


Project Number: 33.15.50

Project Title: PUBLIC WORKS HEADQUARTERS RENOVATION/ALTERATION

GOVERNMENT POST OFFICE  
56 CHURCH STREET, 3RD FLOOR  
HAMILTON

Sheet Title: ELECTRICAL RISER DIAGRAM

Revision: Sheet Number: E7

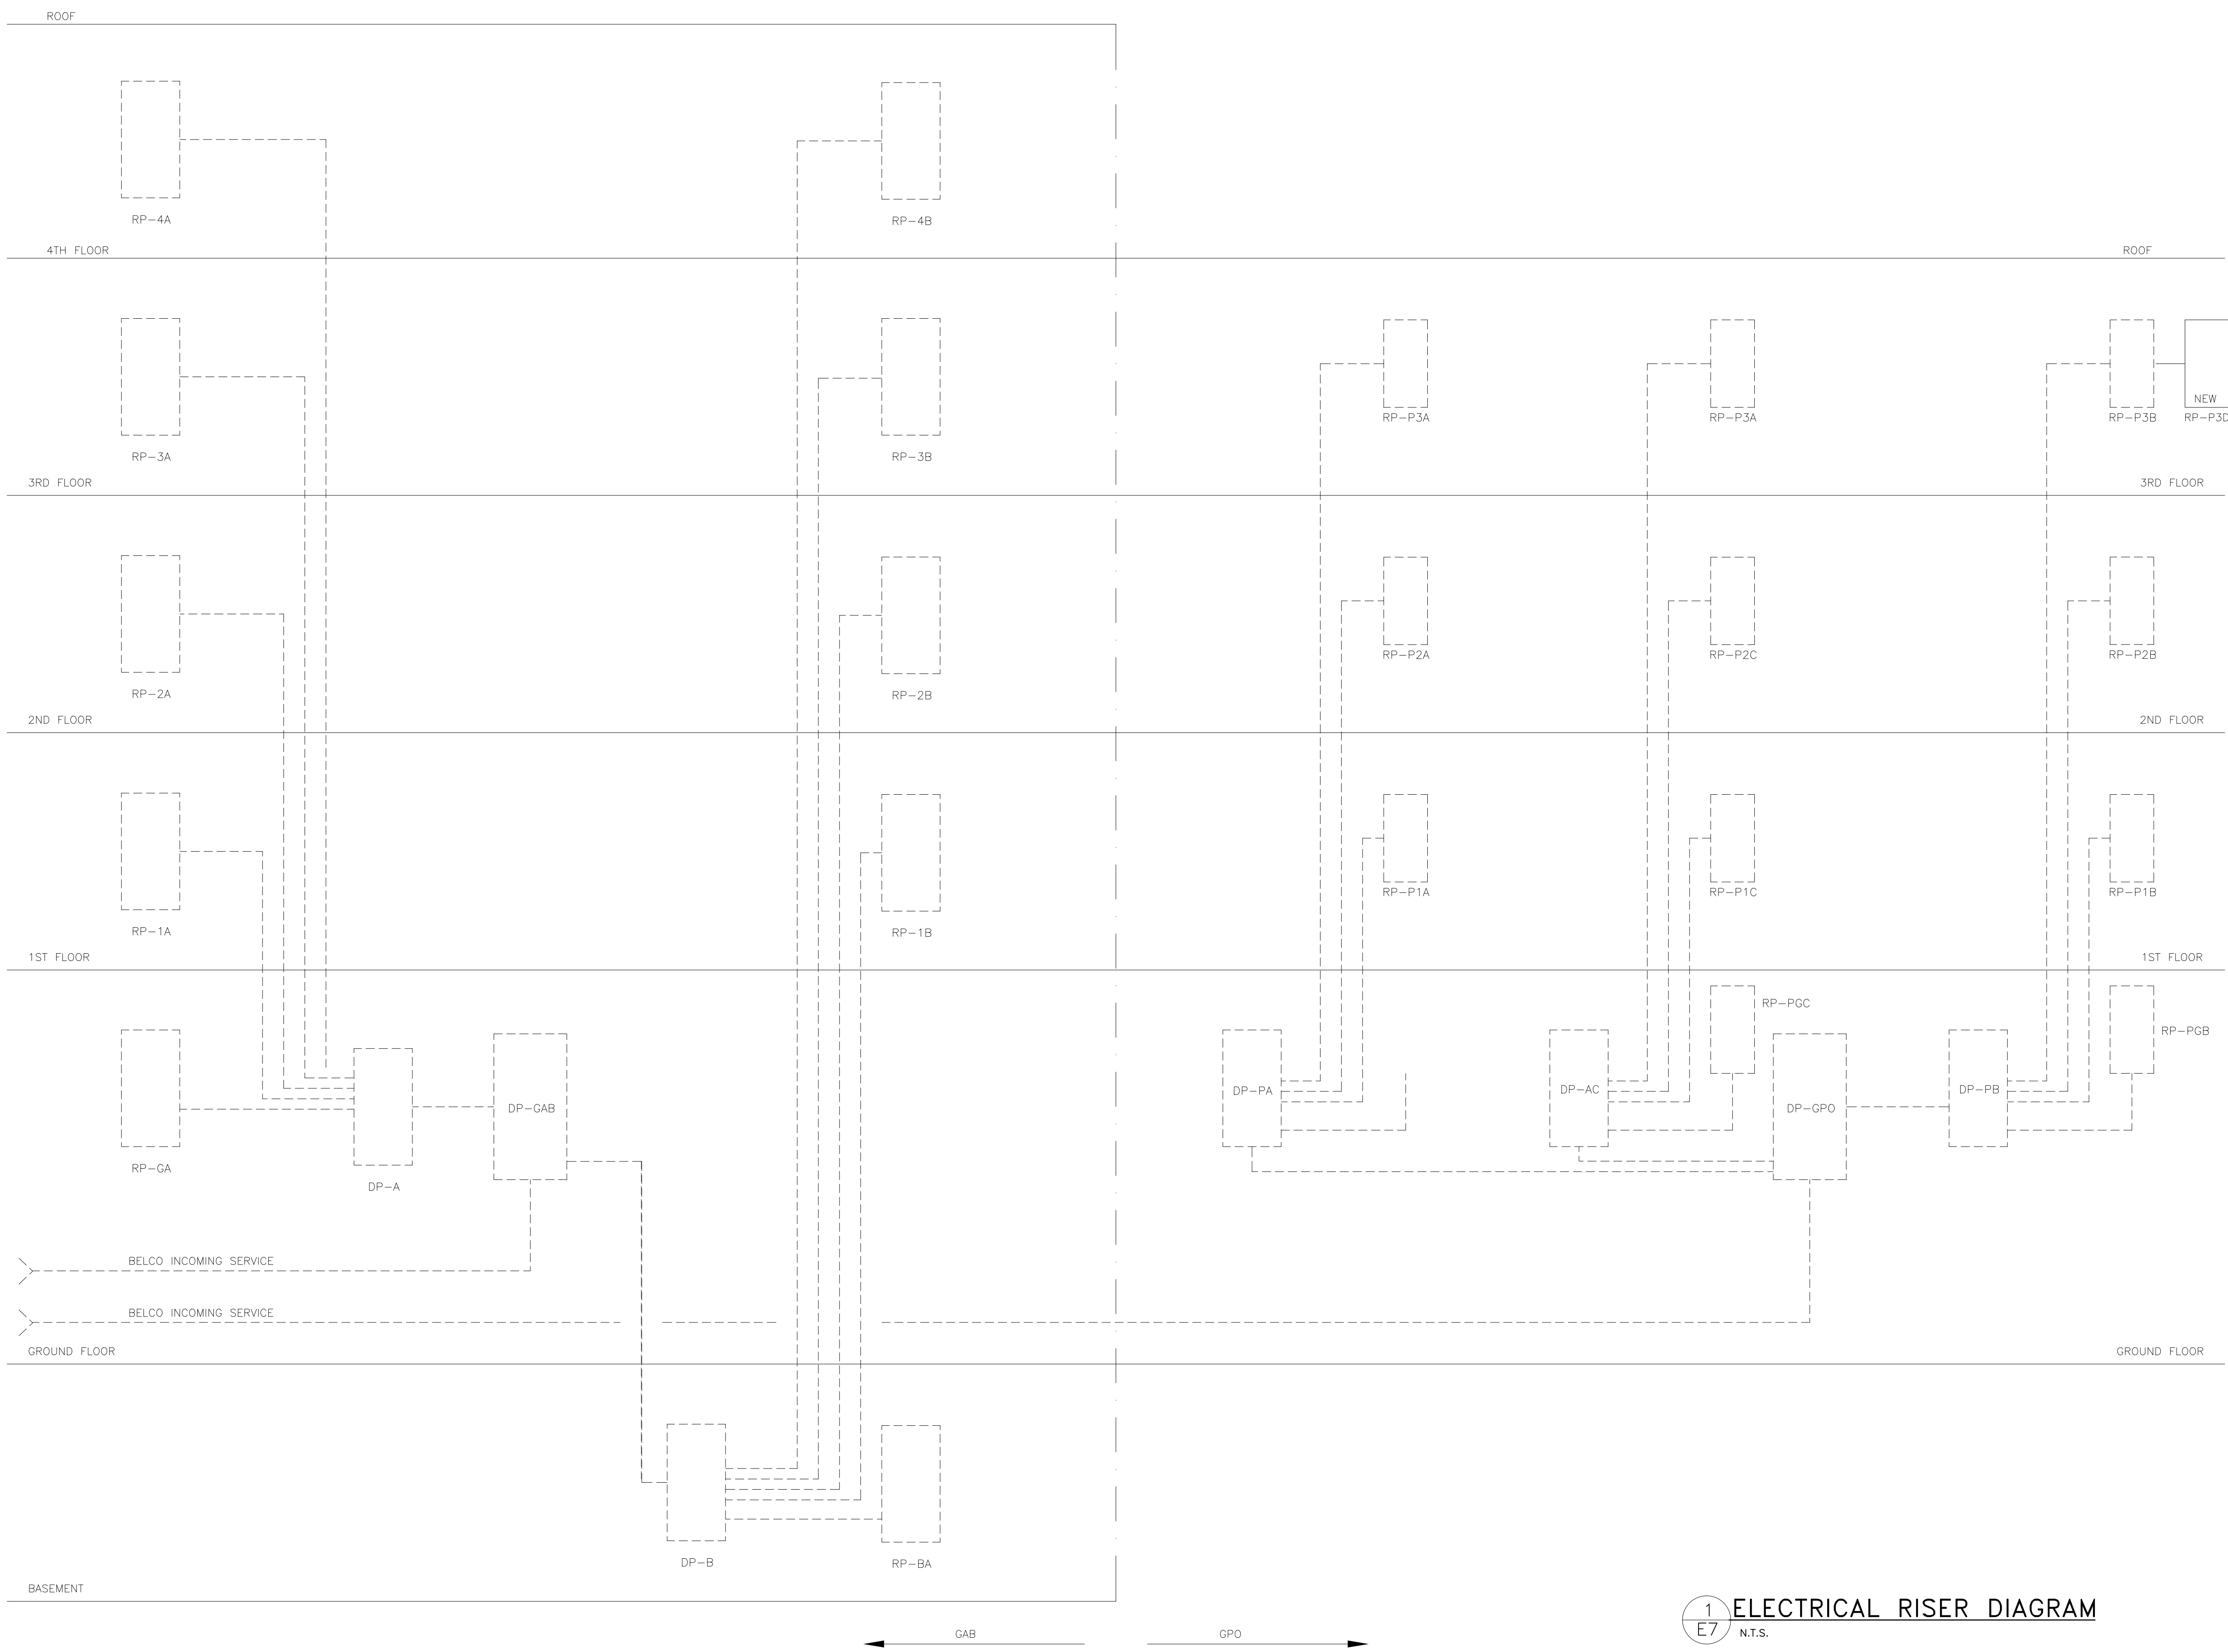

1  
E7  
N.T.S. ELECTRICAL RISER DIAGRAM